


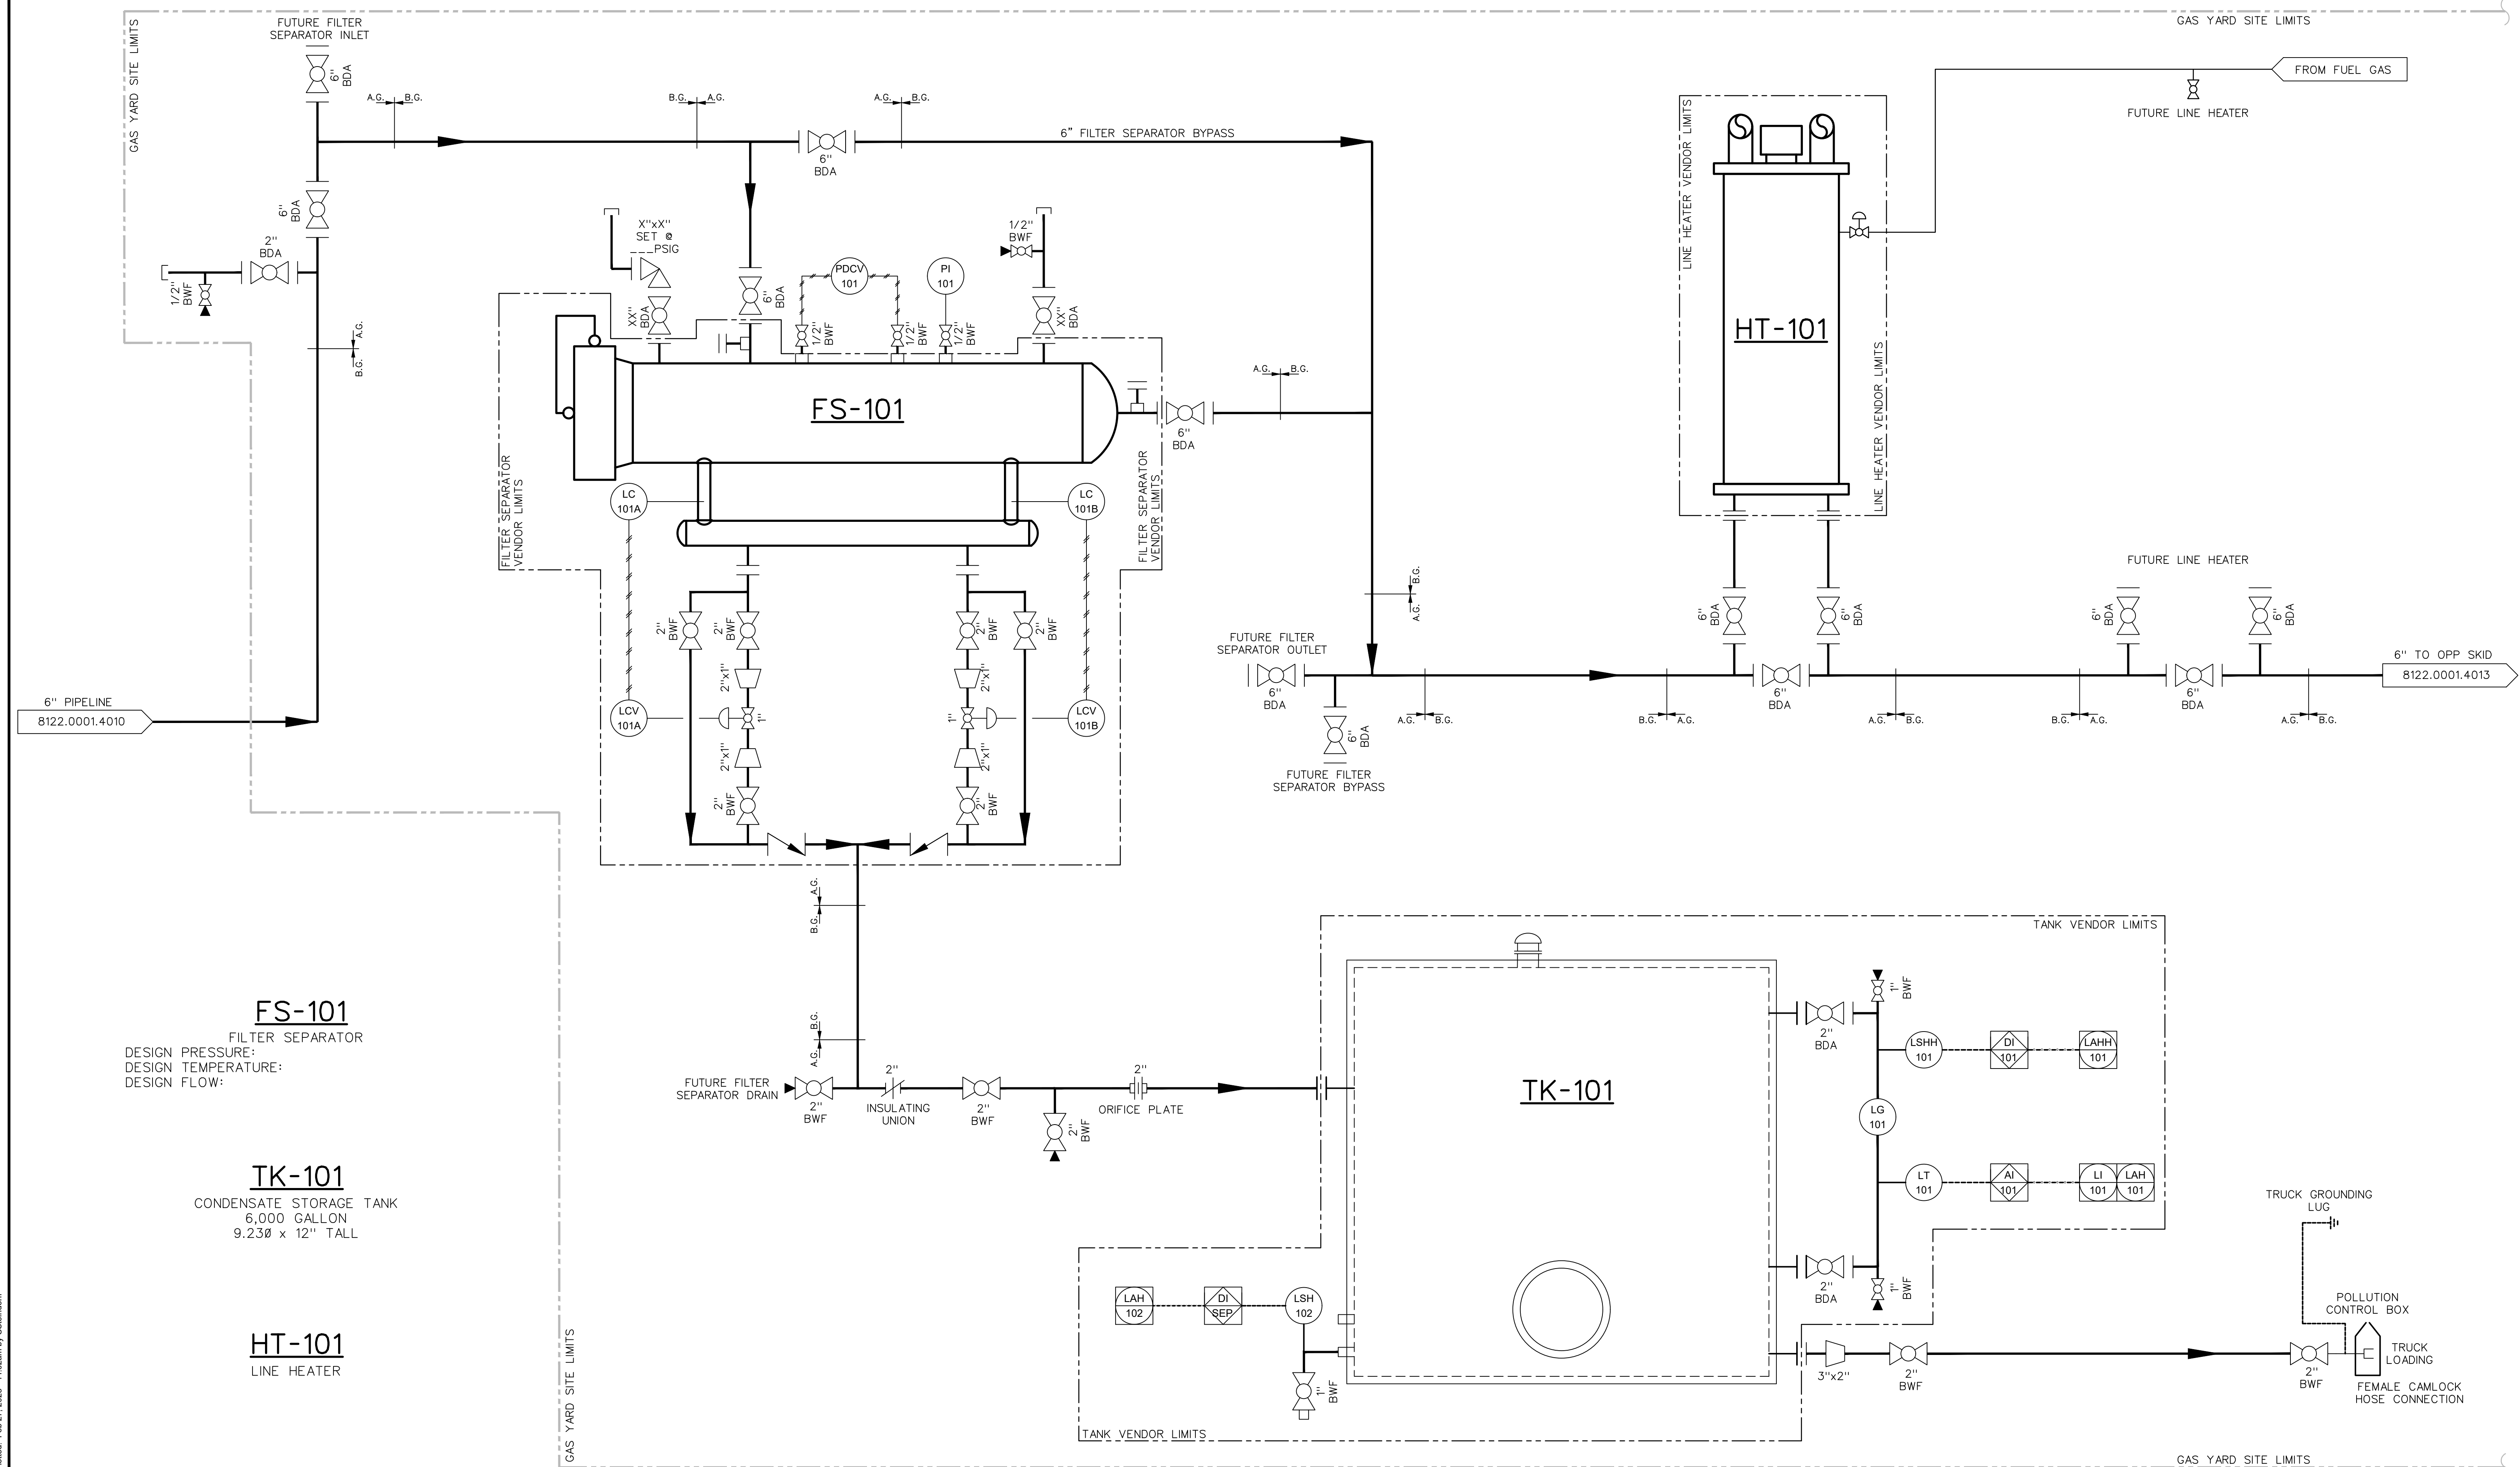

GENERAL NOTES		REFERENCE DRAWINGS		REVISIONS					REVISIONS					DRAWING STATUS			SCALE																											
	DWG. NO.	DESCRIPTION	NO.	DATE	BY	DESCRIPTION	NO.	DATE	BY	DESCRIPTION	NO.	DATE	DESCRIPTION	DRAWN:	DATE:																													
														CHKD:	DATE:																													
														APPROVED:	DATE:																													
	ENSITE JOB NO.:														LEXINGTON, KY 859-873-0076																													
	A/E/P O NO.:																																											
	CLIENT FILE NO.:																																											
	ENSITE FILE NO.:														(2/8122 P&ID.dwg)																													
														www.EnSiteUSA.com																														
																																												
HOUSTON, TX 713-456-7880															LEXINGTON, KY 859-873-0076																													
															PROCESS & INSTRUMENTATION DIAGRAM SHEET 3 OF 4																													
NO.															8122.0001.4012															REV.														