


ULTRA SONIC METER

DESIGN FLOW:

75'x75' METER STATION LIMITS

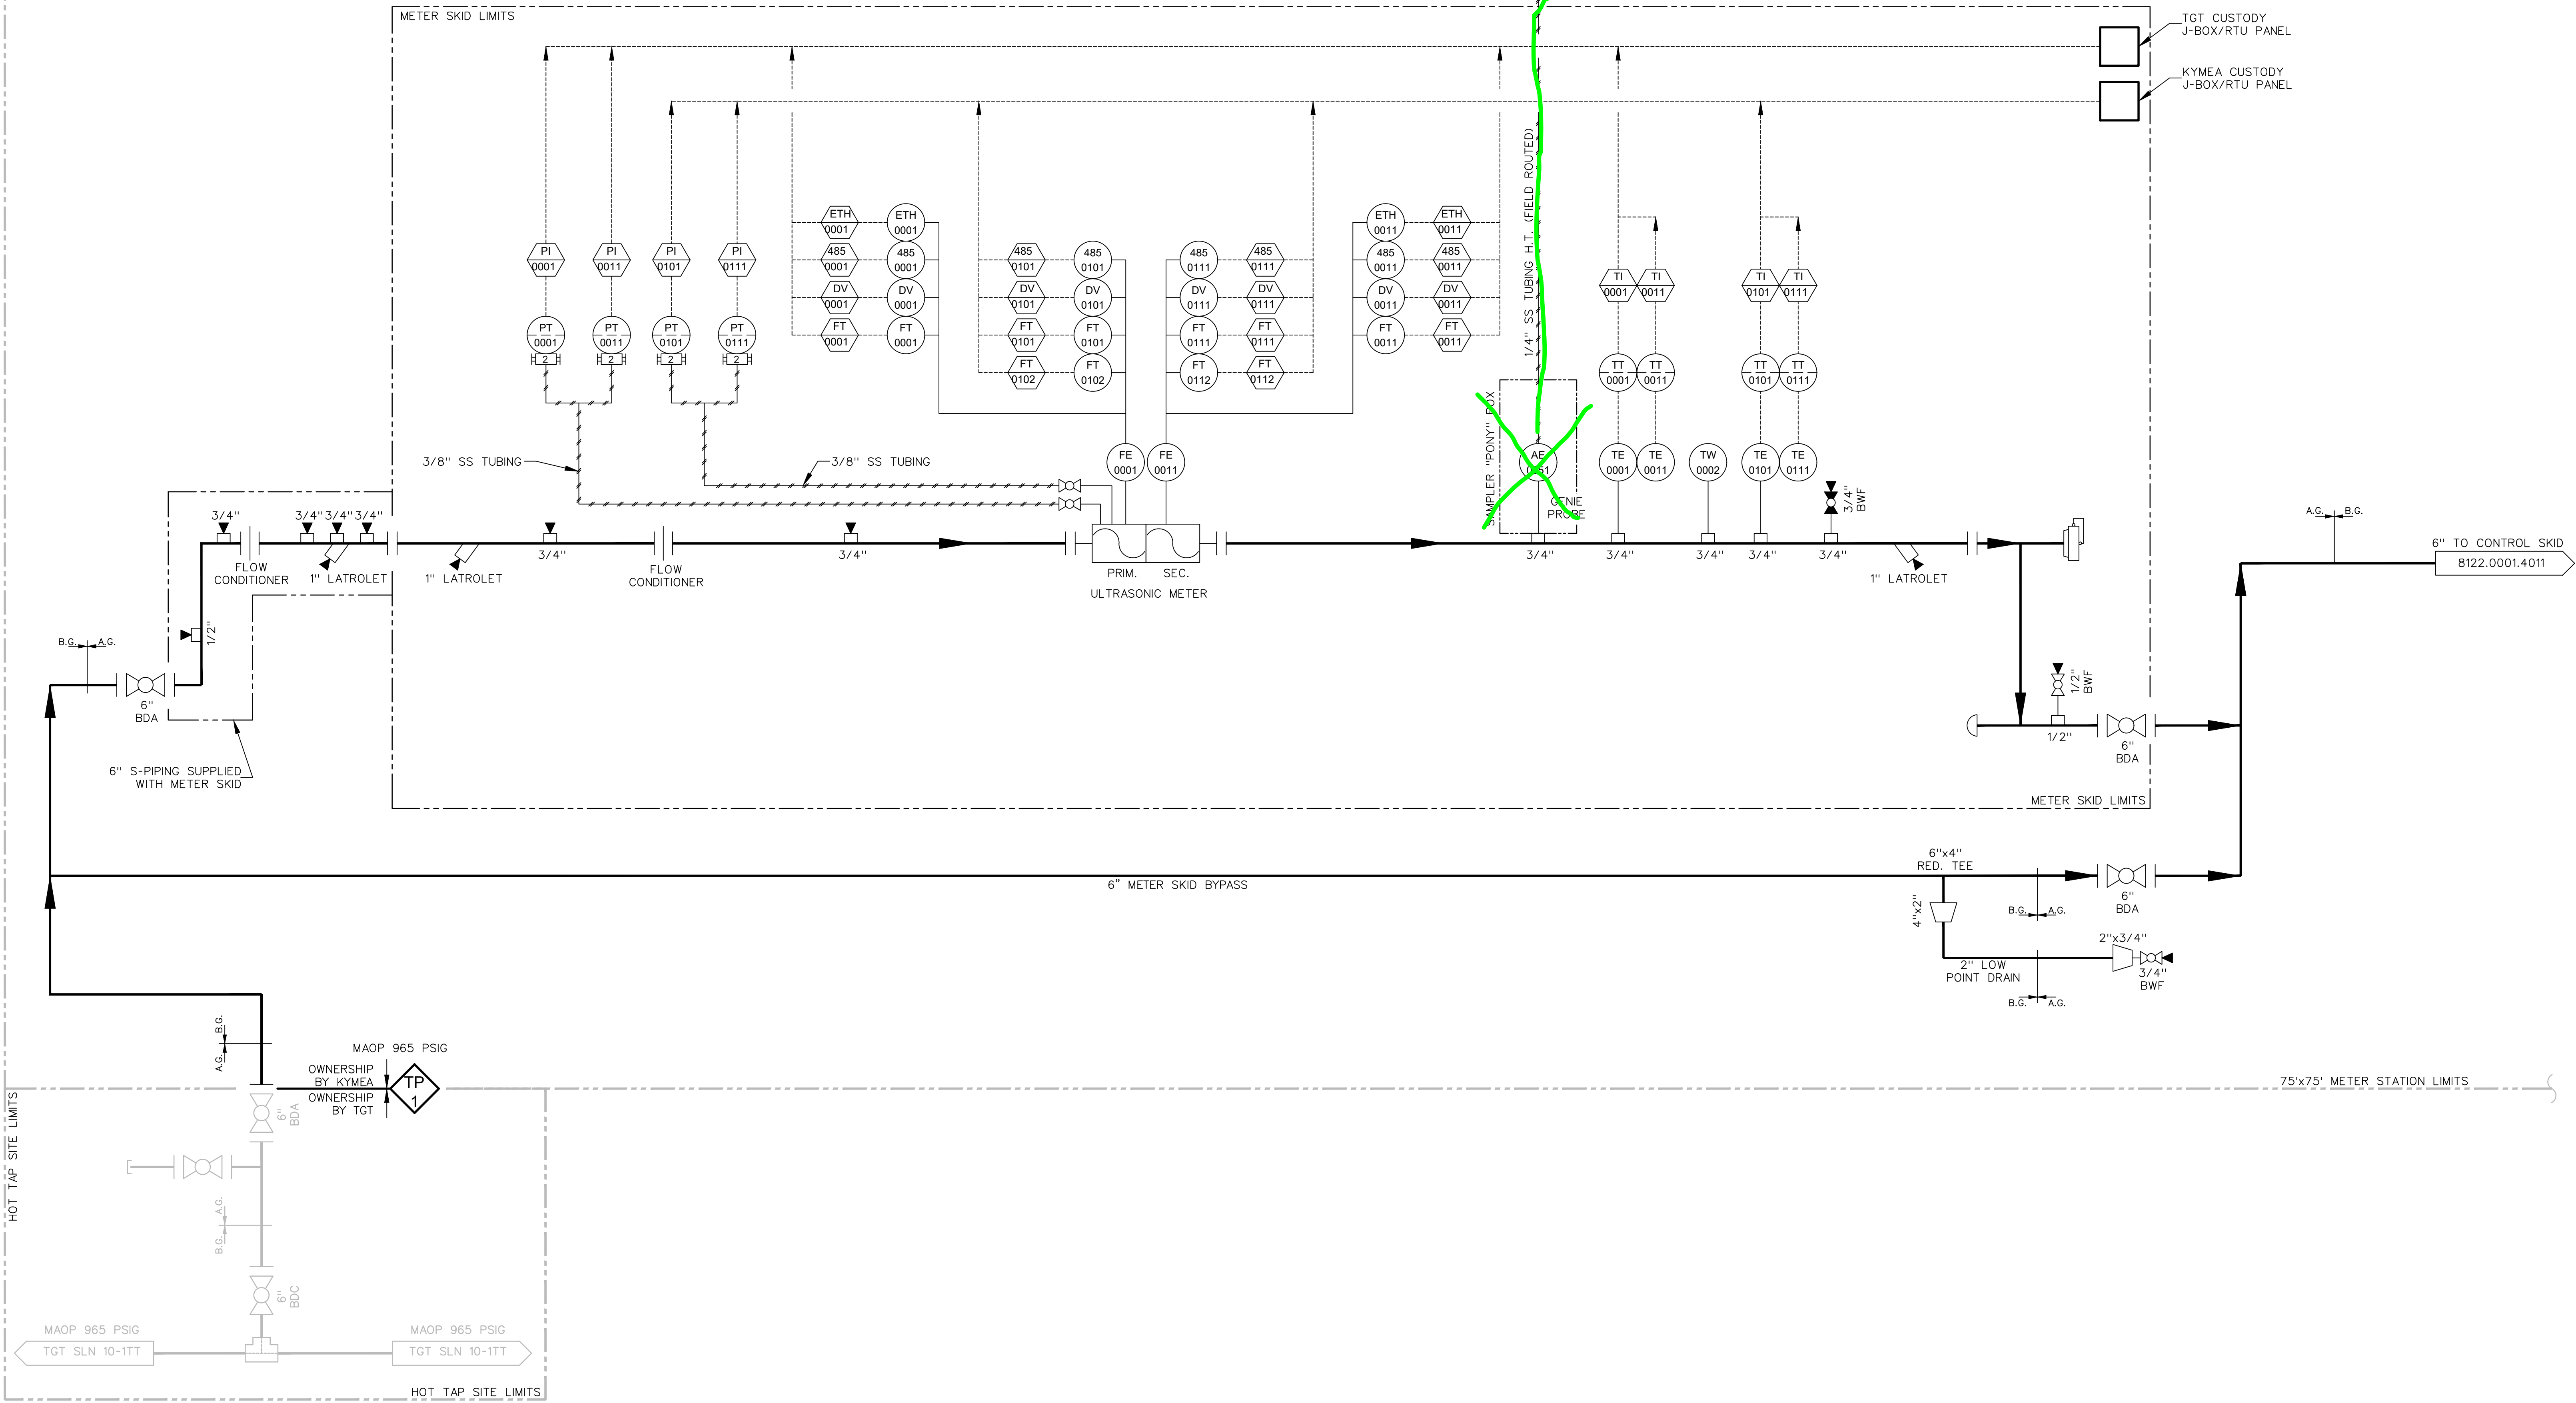

GENERAL NOTES			REFERENCE DRAWINGS			REVISIONS					REVISIONS					DRAWING STATUS			SCALE:		 EnSiteUSA KENTUCKY MUNICIPAL ENERGY AGENCY HOUSTON, TX 713-459-7885 LEXINGTON, KY 606-873-8078 www.EnSiteUSA.com	PROCESS & INSTRUMENTATION DIAGRAM SHEET 1 OF 4		NO.	8122.0001.4010	REV.
DWG. NO.	DESCRIPTION	NO.	DATE	BY	DESCRIPTION	NO.	DATE	BY	DESCRIPTION	NO.	DATE	DESCRIPTION	DRAWN:	DATE:												
															CHK'D:	DATE:										
																APPROVED:	DATE:									
																ENSITE JOB NO.:										
																A/EP/ O.N.O.:										
																CLIENT FILE NO.:										
																	ENSITE FILE NO.:	(28122_P&ID.dwg)								